


TYPE	DESCRIPTION	LOCATION
LTE41	PEDESTRIAN POLE LIGHT, NOM. 14FT POLE.	GROUND LEVEL, LOCAL STREETS
LTE42	ROADWAY POLE LIGHT, ASYMMETRIC THROW, NOM. 14FT POLE.	GROUND LEVEL, PERIMETER STREETS
LTE43A	ROADWAY POLE LIGHT, ASYMMETRIC THROW, NOM. 14FT POLE.	GROUND LEVEL, PERIMETER STREETS
LTE43B	CUSTOM ROADWAY/PEDESTRIAN POLE LIGHT	GROUND LEVEL, NORTH HAYSTACK ROAD
LTE43C		GROUND LEVEL, STEVENS CREEK BLVD
LTE43D		GROUND LEVEL, STEVENS CREEK BLVD
LTE43E		GROUND LEVEL, STEVENS CREEK BLVD
LTE43F		GROUND LEVEL, STEVENS CREEK BLVD
LTE43G		GROUND LEVEL, STEVENS CREEK BLVD
LTE43H		GROUND LEVEL, STEVENS CREEK BLVD
LTE44	ROADWAY POLE LIGHT, ASYMMETRIC THROW, NOM. 14FT OVERALL HEIGHT.	GROUND LEVEL, OFFICE BUILDING DROP-OFF AREAS
LTE45	POLE LIGHT WITH DECORATIVE POLE TOP LUMINAIRE, NOM. 14FT OVERALL HEIGHT.	GROUND LEVEL
LTE46	NOM. 3FT TALL BOLLARD WITH ASYMMETRIC THROW.	GROUND LEVEL
LTE47	NOM. 3FT TALL BOLLARD WITH 360 DEG. DISTRIBUTION.	GROUND LEVEL, PERIMETER SIDEWAYS
LTE48	NOM. 3FT TALL BOLLARD WITH 360 DEG. DISTRIBUTION.	GROUND LEVEL, TOWNHOUSES
LTE49	BUILDING MOUNTED FULL CUT-OFF WALL SCOFF.	GROUND LEVEL, TOWNHOUSES
LTE50	MULTI-HEAD POLE LIGHT, NOM. 18FT OVERALL HEIGHT.	GROUND LEVEL, RETAIL STREET
LTE51	BUILDING MOUNTED FULL CUT-OFF WALL SCOFF.	ROOF DECK, APARTMENTS
LTE52	BULLET LIGHT FOR TREES.	GROUND LEVEL
LTE53	NOM. 3FT TALL BOLLARD WITH ASYMMETRIC THROW, MEDIUM OUTPUT.	ROOF DECK, APARTMENTS
LTE54	NOM. 3FT TALL BOLLARD WITH ASYMMETRIC THROW, HIGH OUTPUT.	ROOF DECK, APARTMENTS
LTE55	BULLET LIGHT FOR TREES.	ROOF DECK, APARTMENTS
LTE56	POLE LIGHT WITH 10" ADJUSTABLE HEAD, NOM. 20FT OVERALL HEIGHT.	ROOF DECK, APARTMENTS
LTE57	EXTERIOR MOUNTED RECESSED NOM. 7" DIAMETER ADJUSTABLE DOWNLIGHT.	BUILDING SOFFITS / CHIMNEYS THROUGHOUT
LTE58	UNDERWATER POLE LIGHT.	ROOF DECK, APARTMENTS
LTE59	OUTDOOR LAMP ON CUSTOM POLE AND ARM, PERIMETER TABLES.	GROUND LEVEL, PERIMETER TABLES
LTE60	EXTERIOR MOUNTED RECESSED NOM. 7" DIAMETER DOWNLIGHT.	GROUND LEVEL, GATEWAY STRUCTURE
LTE61	EXTERIOR MOUNTED RECESSED NOM. 7" DIAMETER DOWNLIGHT.	GROUND LEVEL, GATEWAY STRUCTURE
LTE62	EXTERIOR MOUNTED STRIPLIGHT LIGHTING UP ON UNDERSIDE OF GATEWAY STRUCTURE.	GROUND LEVEL, GATEWAY STRUCTURE
LTE63	EXTERIOR MOUNTED FLEXIBLE STRIPLIGHT FOR PLANTER LIGHTING.	GROUND LEVEL AND ELEVATED TERRACE PLANTERS AND BENCHES
LTE64	EXTERIOR MOUNTED FLEXIBLE STRIPLIGHT FOR UNDERBENCH LIGHTING.	GROUND LEVEL AND ELEVATED TERRACE PLANTERS AND BENCHES
LTE65	EXTERIOR MOUNTED STRIPLIGHT INSTALLED LIGHTING DOWN.	ELEVATED TERRACE STEPS
LTE66	FEETCORN LIGHTING.	GROUND LEVEL, RETAIL PASSE
LTE67	2-HEAD POLE LIGHT, NOM. 14FT OVERALL HEIGHT.	GROUND LEVEL, RETAIL PASSE
LTE68	NOM. 3FT TALL BOLLARD WITH 360 DEG. DISTRIBUTION.	GROUND LEVEL, RESIDENTIAL DROP-OFF
LTE69	EXTERIOR MOUNTED RECESSED 1" DIAMETER MOUNTED IN WALL, AIMED DOWN AT FLOOR.	PEDESTRIAN BRIDGE
LTE70A	EXTERIOR MOUNTED SURFACE MOUNTED WALL SCOFF.	GROUND LEVEL
LTE70B		GROUND LEVEL
LTE70C		GROUND LEVEL
LTE70D		GROUND LEVEL
LTE70E		GROUND LEVEL
LTE71	ROADWAY POLE LIGHT CONNECTED TO STREET LIGHTING GRID. OBTAIN APPROVAL FROM DPW PRIOR TO PURCHASING. INSTALLATION TO COMPLY WITH DPW REQUIREMENTS.	GROUND LEVEL
LTE72	POLE LIGHT, NOM. 18FT OVERALL HEIGHT.	OFFICE BUILDING TERRACES
LTE73	NOM. 3FT TALL BOLLARD WITH 360 DEG. DISTRIBUTION.	OFFICE BUILDING TERRACES
LTE74	UPLIGHT FOR BUILDING SOFFITS / OVERHANGS.	OFFICE BUILDINGS
LTE75	WALL RECESSED STRIPLIGHT.	TERRACE ADJACENT TO RETAIL STREET
LTE76	LED STRIPLIGHT INTEGRATED INTO HANDRAIL, CONTINUOUS LENGTHS.	STEPS ADJACENT TO RETAIL STREET

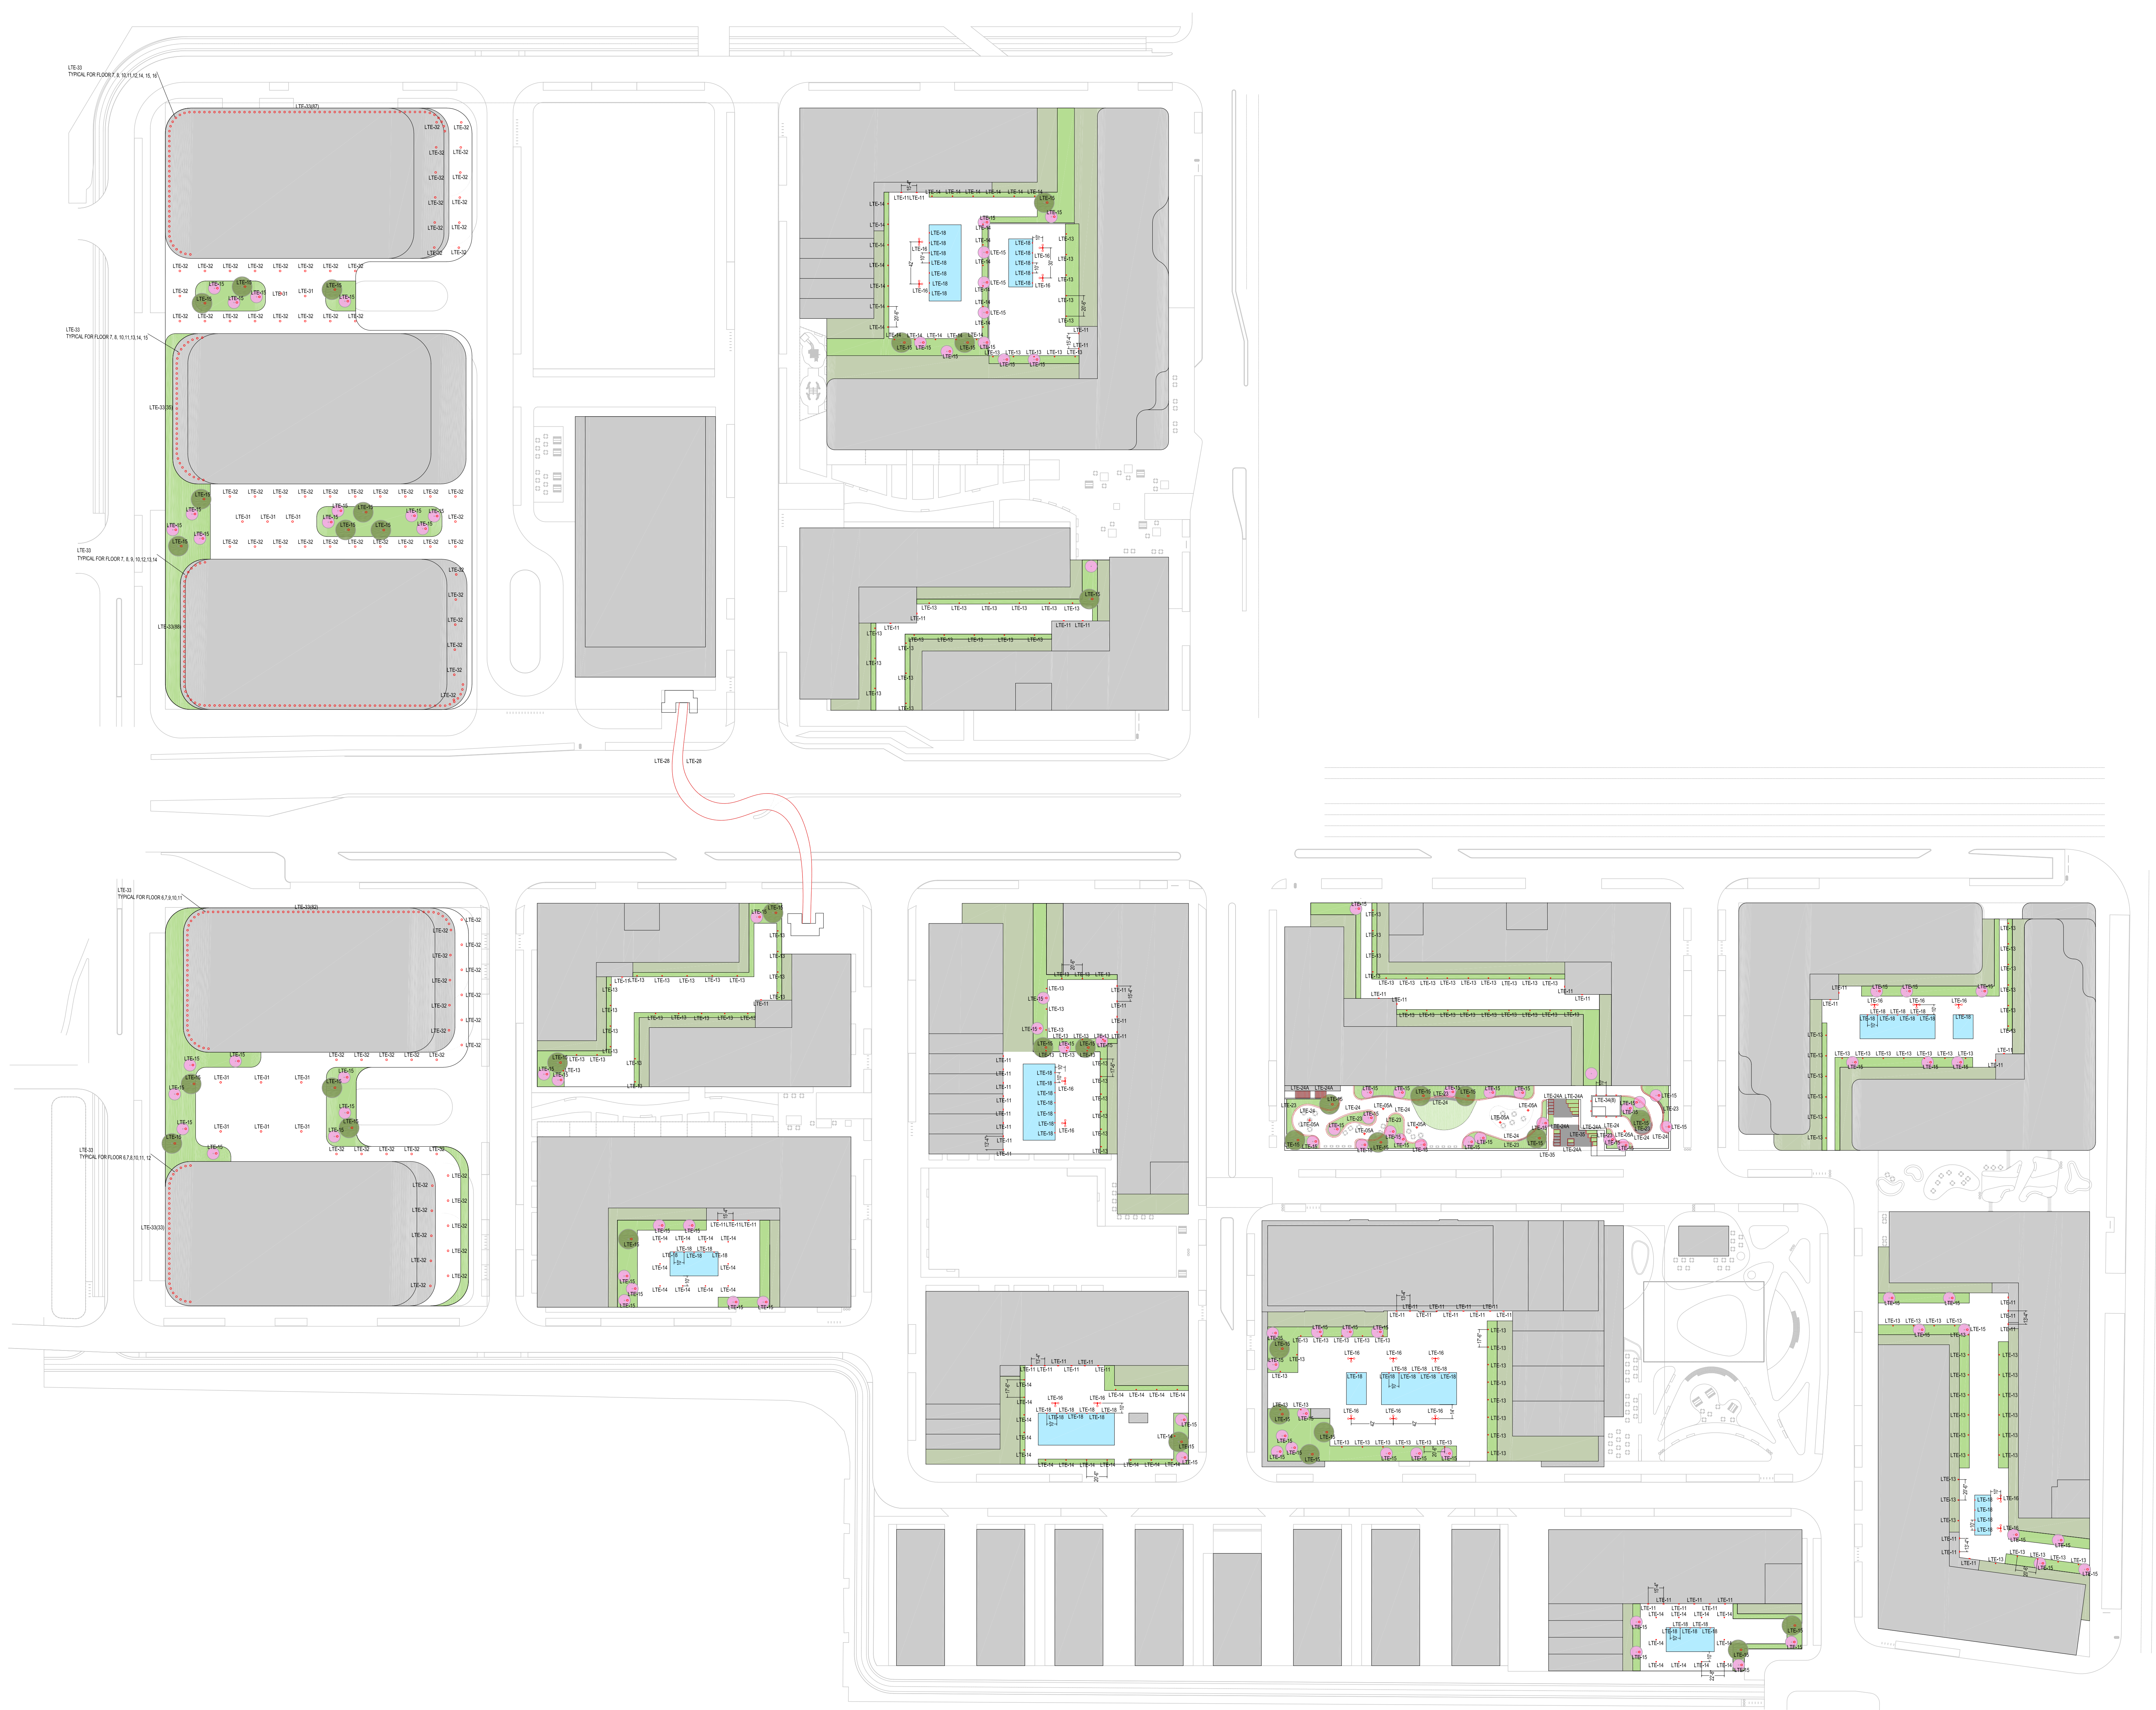

Client

VALLCO PROPERTY OWNER LLC
2000 EL CAMINO REAL, SUITE 410
PALO ALTO, CA 94306
TEL: 650.344.1500

Architecture

KOHN PEDERSEN FOX ASSOCIATES PC
11 WEST 42ND STREET
NEW YORK, NY 10036
TEL: 212.877.6500

Architecture

KOHN PEDERSEN FOX ASSOCIATES PC
2 EMBARCADERO CENTER
SAN FRANCISCO, CA 94111
TEL: 415.944.5491

Landscape Architecture

OLIN
1617 JOHN F. KENNEDY BOULEVARD, SUITE 1900
PHILADELPHIA, PA 19103
TEL: 215.440.0030

Civil

SANDS
1705 S. WINCHESTER BOULEVARD, SUITE 200
CAMPBELL, CA 95113
TEL: 408.638.0000

Lighting Design

ONE LUX STUDIO
158 WEST 29TH STREET, 10TH FLOOR
NEW YORK, NY 10001
TEL: 212.201.5790

Structure

DCI ENGINEERS
135 MAIN STREET, SUITE 1800
SAN FRANCISCO, CA 94105
TEL: 415.781.1505

MEP

MEYERS+ ENGINEERS
98 BATTERY STREET, SUITE 500
SAN FRANCISCO, CA 94111
TEL: 415.432.8101

Geotechnical

LANGRISH
1 ALMADEN BOULEVARD, SUITE 500
SAN JOSE, CA 95113
TEL: 408.263.3000

Traffic

KIMLEY-HORN
10 SOUTH ALMADEN BOULEVARD, SUITE 1250
SAN JOSE, CA 95113
TEL: 408.800.4130

Parking Engineering

WATRY DESIGN, INC.
2000 GATEWAY PLACE, SUITE 650
SAN JOSE, CA 95110
TEL: 833.917.7275

Logistics


ARUP
600 MISSION STREET, SUITE 700
SAN FRANCISCO, CA 94105
TEL: 415.957.9445

SB 35 MODIFICATION APPLICATION

Revision

No.	Description	Date
REV-4	SB-35 MODIFICATION APPLICATION	12/04/2023
REV-3	SB-35 MODIFICATION APPLICATION	10/21/2023
REV-2	SB-35 APPLICATION CONFORM SET	09/15/2023
REV-1	SB-35 APPLICATION - REVISION	08/02/2023
REV-0	SB-35 DEVELOPMENT APPLICATION	03/27/2023

No.	Description	Date
15		
14		
13		
12		
11		
10		
9		
8		
7		
6		
5		
4		
3		
2		
1		

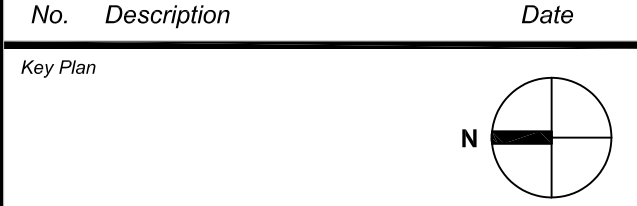

Scale & Signature

NOT FOR CONSTRUCTION

Issue Date: 2023.12.04 Project No: Project Number
Scale: 1/8" = 1'-0"

EXTERIOR LIGHTING PLAN - ROOF / TERRACES

P-0702