

OWNER - VALCO PROPERTY OWNER LLC
2600 EL CAMINO REAL, SUITE 410, PALO ALTO, CA 94308
T. 650-344-1000

ARCHITECTURE - RAFAEL VINOLY ARCHITECTS
315 PEARL STREET, 31ST FLOOR, NEW YORK, NY 10038
T. 212-624-0000

ARCHITECTURE - RAFAEL VINOLY ARCHITECTS
10123 N. WOLFE ROAD, CUPERTINO, CA 95014
T. 408-627-7090

LANDSCAPE ARCHITECTURE - OLIN PARTNERSHIP LTD.
1817 JOHN F. KENNEDY BLVD., SUITE 1000, PHILADELPHIA, PA 19103
T. 215-440-0030

CIVIL - SANDS CIVIL ENGINEERS SURVEYORS PLANNERS, INC.
1700 S. WINCHESTER BLVD., SUITE 200, CAMPBELL, CA 95008
T. 408-636-0000


TRAFFIC - KIMLEY-HORN AND ASSOCIATES, INC.
100 W. SAN FERNANDO STREET, SUITE 250, SAN JOSE, CA 95113
T. 669-800-4130

LIGHTING DESIGN - ONE LUX STUDIO
198 WEST 29TH STREET, 10TH FLOOR, NEW YORK, NY 10011
T. 212-201-5750

SIGNAGE & WAYFINDING - EXIT DESIGN
725 N. 4TH STREET, PHILADELPHIA, PA 19123
T. 215-651-1550

PARKING ENGINEERING - WATRY DESIGN, INC.
2099 GATEWAY PLACE, SUITE 550, SAN JOSE, CA 95110
T. 408-360-7000

FOOD SERVICE, WASTE MANAGEMENT & LOGISTICS - CHN+LITTLE
156 2ND STREET, SAN FRANCISCO, CA 94105
T. 415-922-5900

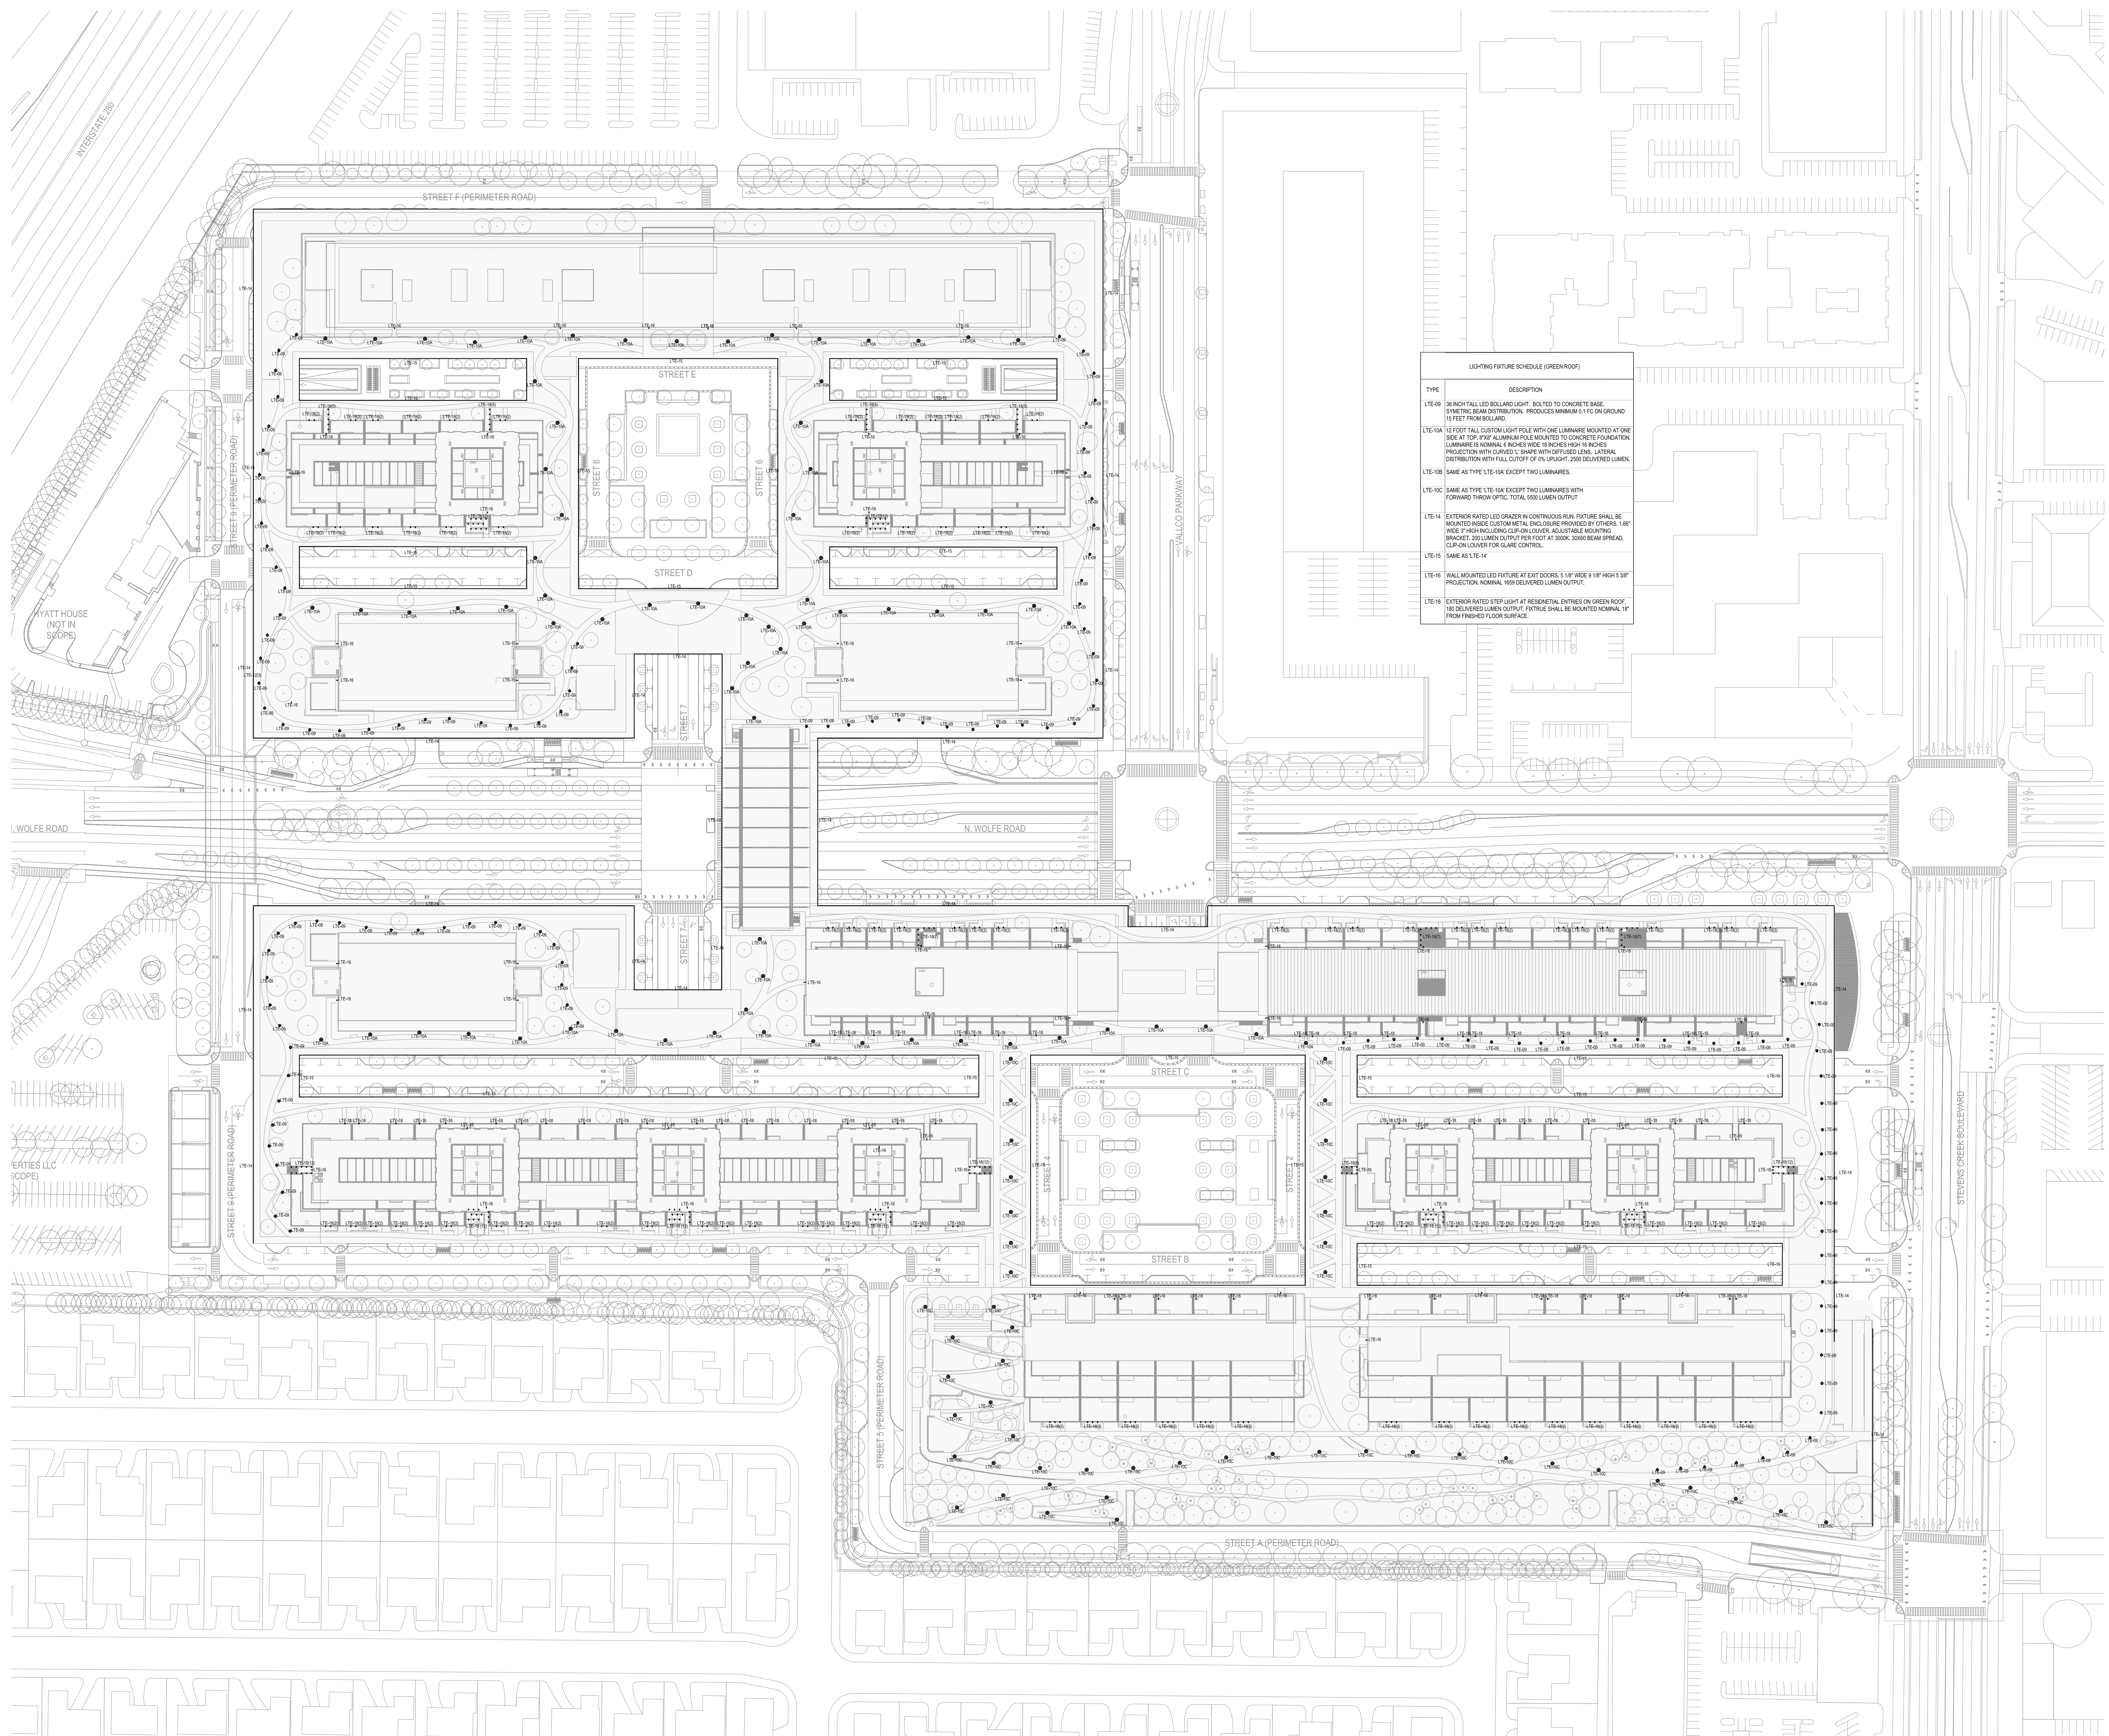

LIGHTING FIXTURE SCHEDULE (GREEN ROOF)


TYPE	DESCRIPTION
L1E-01	36 INCH TALL LED BOLLARD LIGHT, BOLTED TO CONCRETE BASE. SYMMETRIC BEAM DISTRIBUTION. PRODUCES MINIMUM 0.1 FC ON GROUND 10 FEET FROM BOLLARD.
L1E-10A	12 FOOT TALL CUSTOM LIGHT POLE WITH ONE LUMINAIRE MOUNTED AT ONE SIDE AT 100' PIP ALUMINUM POLE MOUNTED TO CONCRETE FOUNDATION. LUMINAIRE IS NOMINAL 8 INCHES WIDE 18 INCHES HIGH 14 INCHES PROJECTION WITH CHAIRED 'I' SHAPE WITH RUFFLED LENS. LENSIAL DISTRIBUTION WITH FULL CUTOFF OF 0% UPLIGHT. 2000 DELIVERED LUMEN.
L1E-10B	SAME AS TYPE L1E-10A EXCEPT TWO LUMINAIRES.
L1E-10C	SAME AS TYPE L1E-10A EXCEPT TWO LUMINAIRES WITH FORWARD THROW OPTIC. TOTAL 5000 LUMEN OUTPUT.
L1E-14	EXTERIOR RATED LED GRABER IN CONTIGUOUS RUN. FIXTURE SHALL BE MOUNTED INSIDE CUSTOM METAL ENCLOSURE PROVIDED BY OTHERS. 14" WIDE 7" HIGH INCLUDING CLIP-ON LOUVER. ADJUSTABLE MOUNTING BRACKET. 200 LUMEN OUTPUT PER FOOT AT 3000'. 3000 BEAM SPREAD. CLIP-ON LOUVER FOR GLARE CONTROL.
L1E-15	SAME AS L1E-14
L1E-16	WALL MOUNTED LED FIXTURE AT EXIT DOORS. 5 1/2" WIDE 9 1/2" HIGH 3/4" PROJECTION. NOMINAL 1600 DELIVERED LUMEN OUTPUT.
L1E-18	EXTERIOR RATED STEP LIGHT AT RECREATIONAL ENTRIES ON GREEN ROOF. 14" DIA. 200 LUMEN OUTPUT. FIXTURE SHALL BE MOUNTED NOMINAL 10" FROM FINISHED FLOOR SURFACE.

NOT FOR CONSTRUCTION
STAMP SIGNATURE

DISCLAIMER
THE ARCHITECT/ENGINEER SHALL HAVE NO RESPONSIBILITY FOR ANY LIABILITY, LOSS, COST, DAMAGE OR EXPENSE ARISING FROM OR RELATING TO ANY USE OF THIS DOCUMENT FOR ANY PURPOSE OTHER THAN ITS INTENDED PURPOSE ON THIS PROJECT. THIS DOCUMENT IS TO BE CONSIDERED IN CONJUNCTION WITH ALL RELATED DOCUMENTATION. ANY DISCREPANCIES IDENTIFIED IN THIS DOCUMENT MUST BE REPORTED IMMEDIATELY TO THE ARCHITECT BEFORE PROCEEDING. CONTRACTORS MUST VERIFY ALL DIMENSIONS PRIOR TO PROCEEDING WITH ANY WORK. ONLY FIGURED DIMENSIONS ARE TO BE USED FOR VERIFICATION.

SB-35 MODIFICATION APPLICATION

REV	DESCRIPTION	DATE
REV-0	SB-35 DEVELOPMENT APPLICATION	03/27/2018
REV-1	SB-35 APPLICATION - REVISION	08/06/2018
REV-2	SB-35 APPLICATION CONFORM SET	01/15/2019
REV-3	SB-35 MODIFICATION APPLICATION	03/23/2022

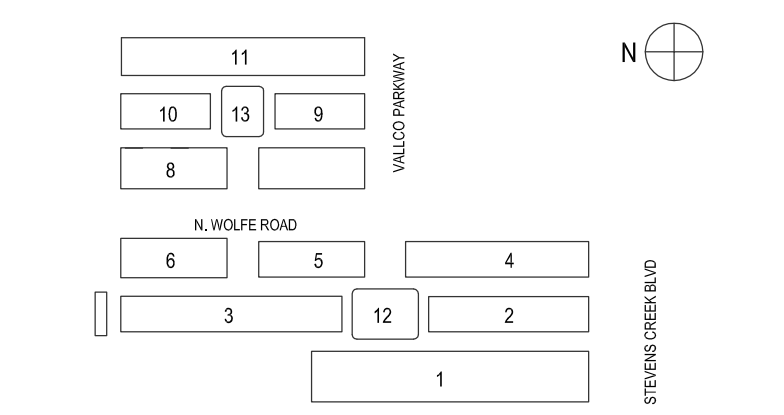

KEY PLAN AND NORTH ARROW
ARCHITECTS PROJECT NUMBER 708.012

IF THIS DRAWING IS NOT 36"x48" IT IS A REDUCED PRINT:
REFER TO GRAPHIC SCALE



EXTERIOR LIGHTING PLAN - GREEN ROOF

SHEET TITLE:

P-0702
SHEET NUMBER