

LIGHTING FIXTURE SCHEDULE (GREEN ROOM)


TYPE	DESCRIPTION
LFE-09	36 INCH TALL LED BOLLARD LIGHT. BOLTED TO CONCRETE BASE. SYMMETRIC BEAM DISTRIBUTION. PRODUCES MINIMUM 0.1 FC ON GROUND 10 FEET FROM BOLLARD.
LFE-10A	12 FOOT TALL CUSTOM LIGHT POLE WITH ONE LUMINAIRE MOUNTED AT ONE SIDE AT 100' PIP ALUMINUM POLE MOUNTED TO CONCRETE FOUNDATION. LUMINAIRE IS NOMINAL 8 INCHES WIDE 18 INCHES HIGH 14 INCHES PROJECTION WITH GRATED 1' SHADE WITH DIFFUSED LENS. LATERAL DISTRIBUTION WITH FULL CUTOFF OF 0% UPLIGHT. 2000 DELIVERED LUMEN.
LFE-10B	SAME AS TYPE LFE-10A EXCEPT TWO LUMINAIRES.
LFE-10C	SAME AS TYPE LFE-10A EXCEPT TWO LUMINAIRES WITH FORWARD THROW OPTIC. TOTAL 5000 LUMEN OUTPUT.
LFE-14	EXTERIOR RATED LED GRATER IN CONTIGUOUS RAIL. FIXTURE SHALL BE MOUNTED INSIDE CUSTOM METAL ENCLOSURE PROVIDED BY OTHERS. 1.6M WIDE 2' HIGH INCLUDING CLIP-ON LOUVER. ADJUSTABLE MOUNTING BRACKET 200 LUMEN OUTPUT PER FOOT AT 3000K. 3000 BEAM SPREAD. CLIP-ON LOUVER FOR GLARE CONTROL.
LFE-15	SAME AS LFE-14
LFE-16	WALL MOUNTED LED FIXTURE AT EXIT DOORS. 5.1M WIDE 9.1M HIGH 5.8M PROJECTION. NOMINAL 1600 DELIVERED LUMEN OUTPUT.
LFE-18	EXTERIOR RATED STEP LIGHT AT RECESSED METAL ENTRIES ON GREEN ROOF. 140 DELIVERED LUMEN OUTPUT. OUTLET SHALL BE MOUNTED NOMINAL 10' FROM FINISHED FLOOR SURFACE.

NOT FOR CONSTRUCTION  
 STAMP SIGNATURE

DISCLAIMER  
 THE ARCHITECT/ENGINEER SHALL HAVE NO RESPONSIBILITY FOR ANY LIABILITY, LOSS, COST, DAMAGE OR EXPENSE ARISING FROM OR RELATING TO ANY USE OF THIS DOCUMENT FOR ANY PURPOSE OTHER THAN ITS INTENDED PURPOSE ON THIS PROJECT. THIS DOCUMENT IS TO BE CONSIDERED IN CONJUNCTION WITH ALL RELATED DOCUMENTATION. ANY DISCREPANCIES IDENTIFIED IN THIS DOCUMENT MUST BE REPORTED IMMEDIATELY TO THE ARCHITECT BEFORE PROCEEDING. CONTRACTORS MUST VERIFY ALL DIMENSIONS PRIOR TO PROCEEDING WITH ANY WORK. ONLY FIGURED DIMENSIONS ARE TO BE USED FOR VERIFICATION.

SB-35 MODIFICATION APPLICATION

REV	DESCRIPTION	DATE
REV-0	SB-35 DEVELOPMENT APPLICATION	03/27/2018
REV-1	SB-35 APPLICATION - REVISION	08/05/2018
REV-2	SB-35 APPLICATION CONFORM SET	01/15/2019
REV-3	SB-35 MODIFICATION APPLICATION	03/23/2022

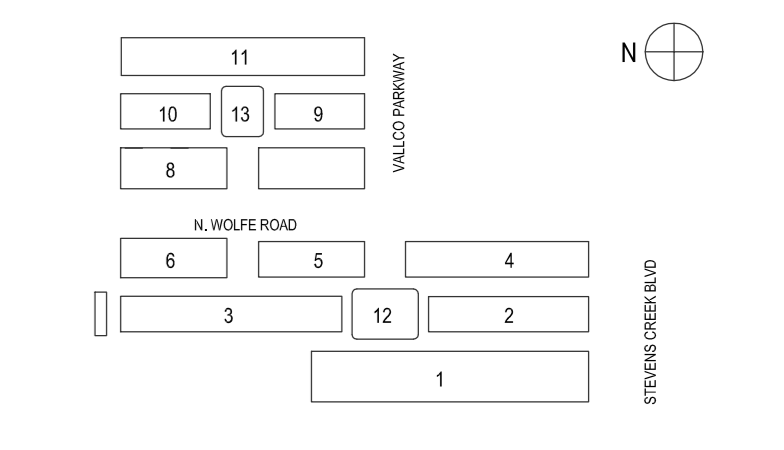

KEY PLAN AND NORTH ARROW  
 ARCHITECTS PROJECT NUMBER 708.012

IF THIS DRAWING IS NOT 36"x48" IT IS A REDUCED PRINT:  
 REFER TO GRAPHIC SCALE

SCALE: 1/8"=1'-0"

EXTERIOR LIGHTING PLAN - GREEN ROOF

SHEET TITLE: